





PLAN

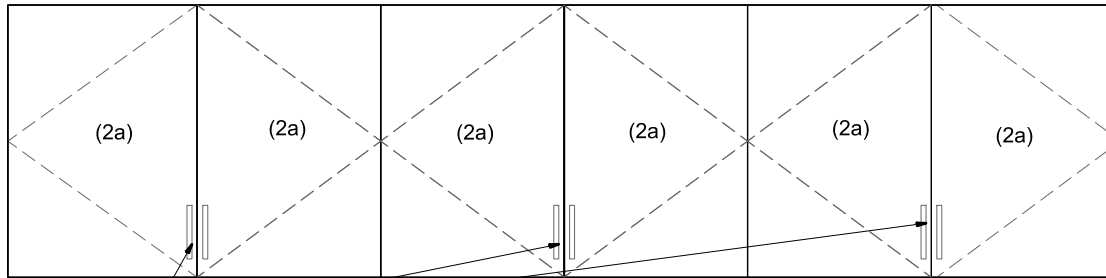


S/S HANDLE

1800

FRONT ELEVATION

-  13amp socket outlet
-  data socket outlet
-  phone socket outlet

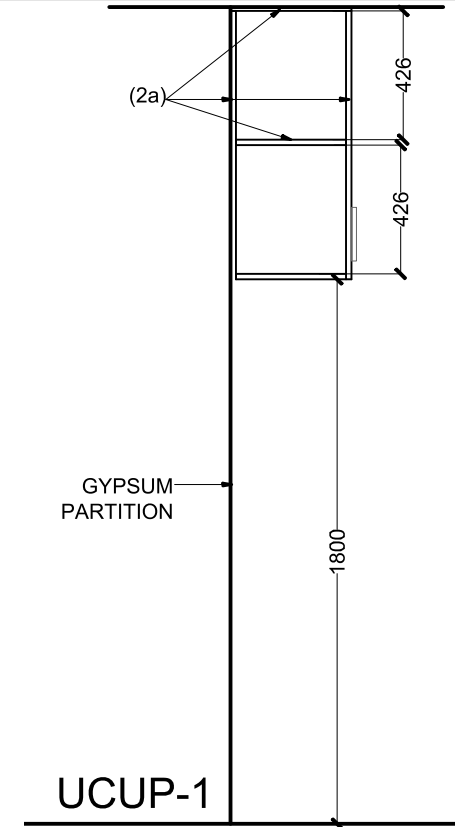

SECTION-X-X

UCUP-1

CUPBOARDS

PROJECT:			
PUBLIC UTILITIES COMMISSION OF SRI LANKA 6TH FLOOR , BOC MERCHANT TOWER ST. MICHAEL'S ROAD, COLOMBO 3			
DATE: 04.03.2019	DRAWN: RAS	SCALE: 1:25	PAPER: A4
RASIKA RANAWAKA (BSC -BE, MSC-ARCH, AIA SL) CHARTERED ARCHITECT AND INTERIOR DESIGNER NO: 130/04, TEMPLE ROAD, DIYAKADUWA, MAHAGAMA. TEL: +94772626007, MOBILE: +94773431544			